


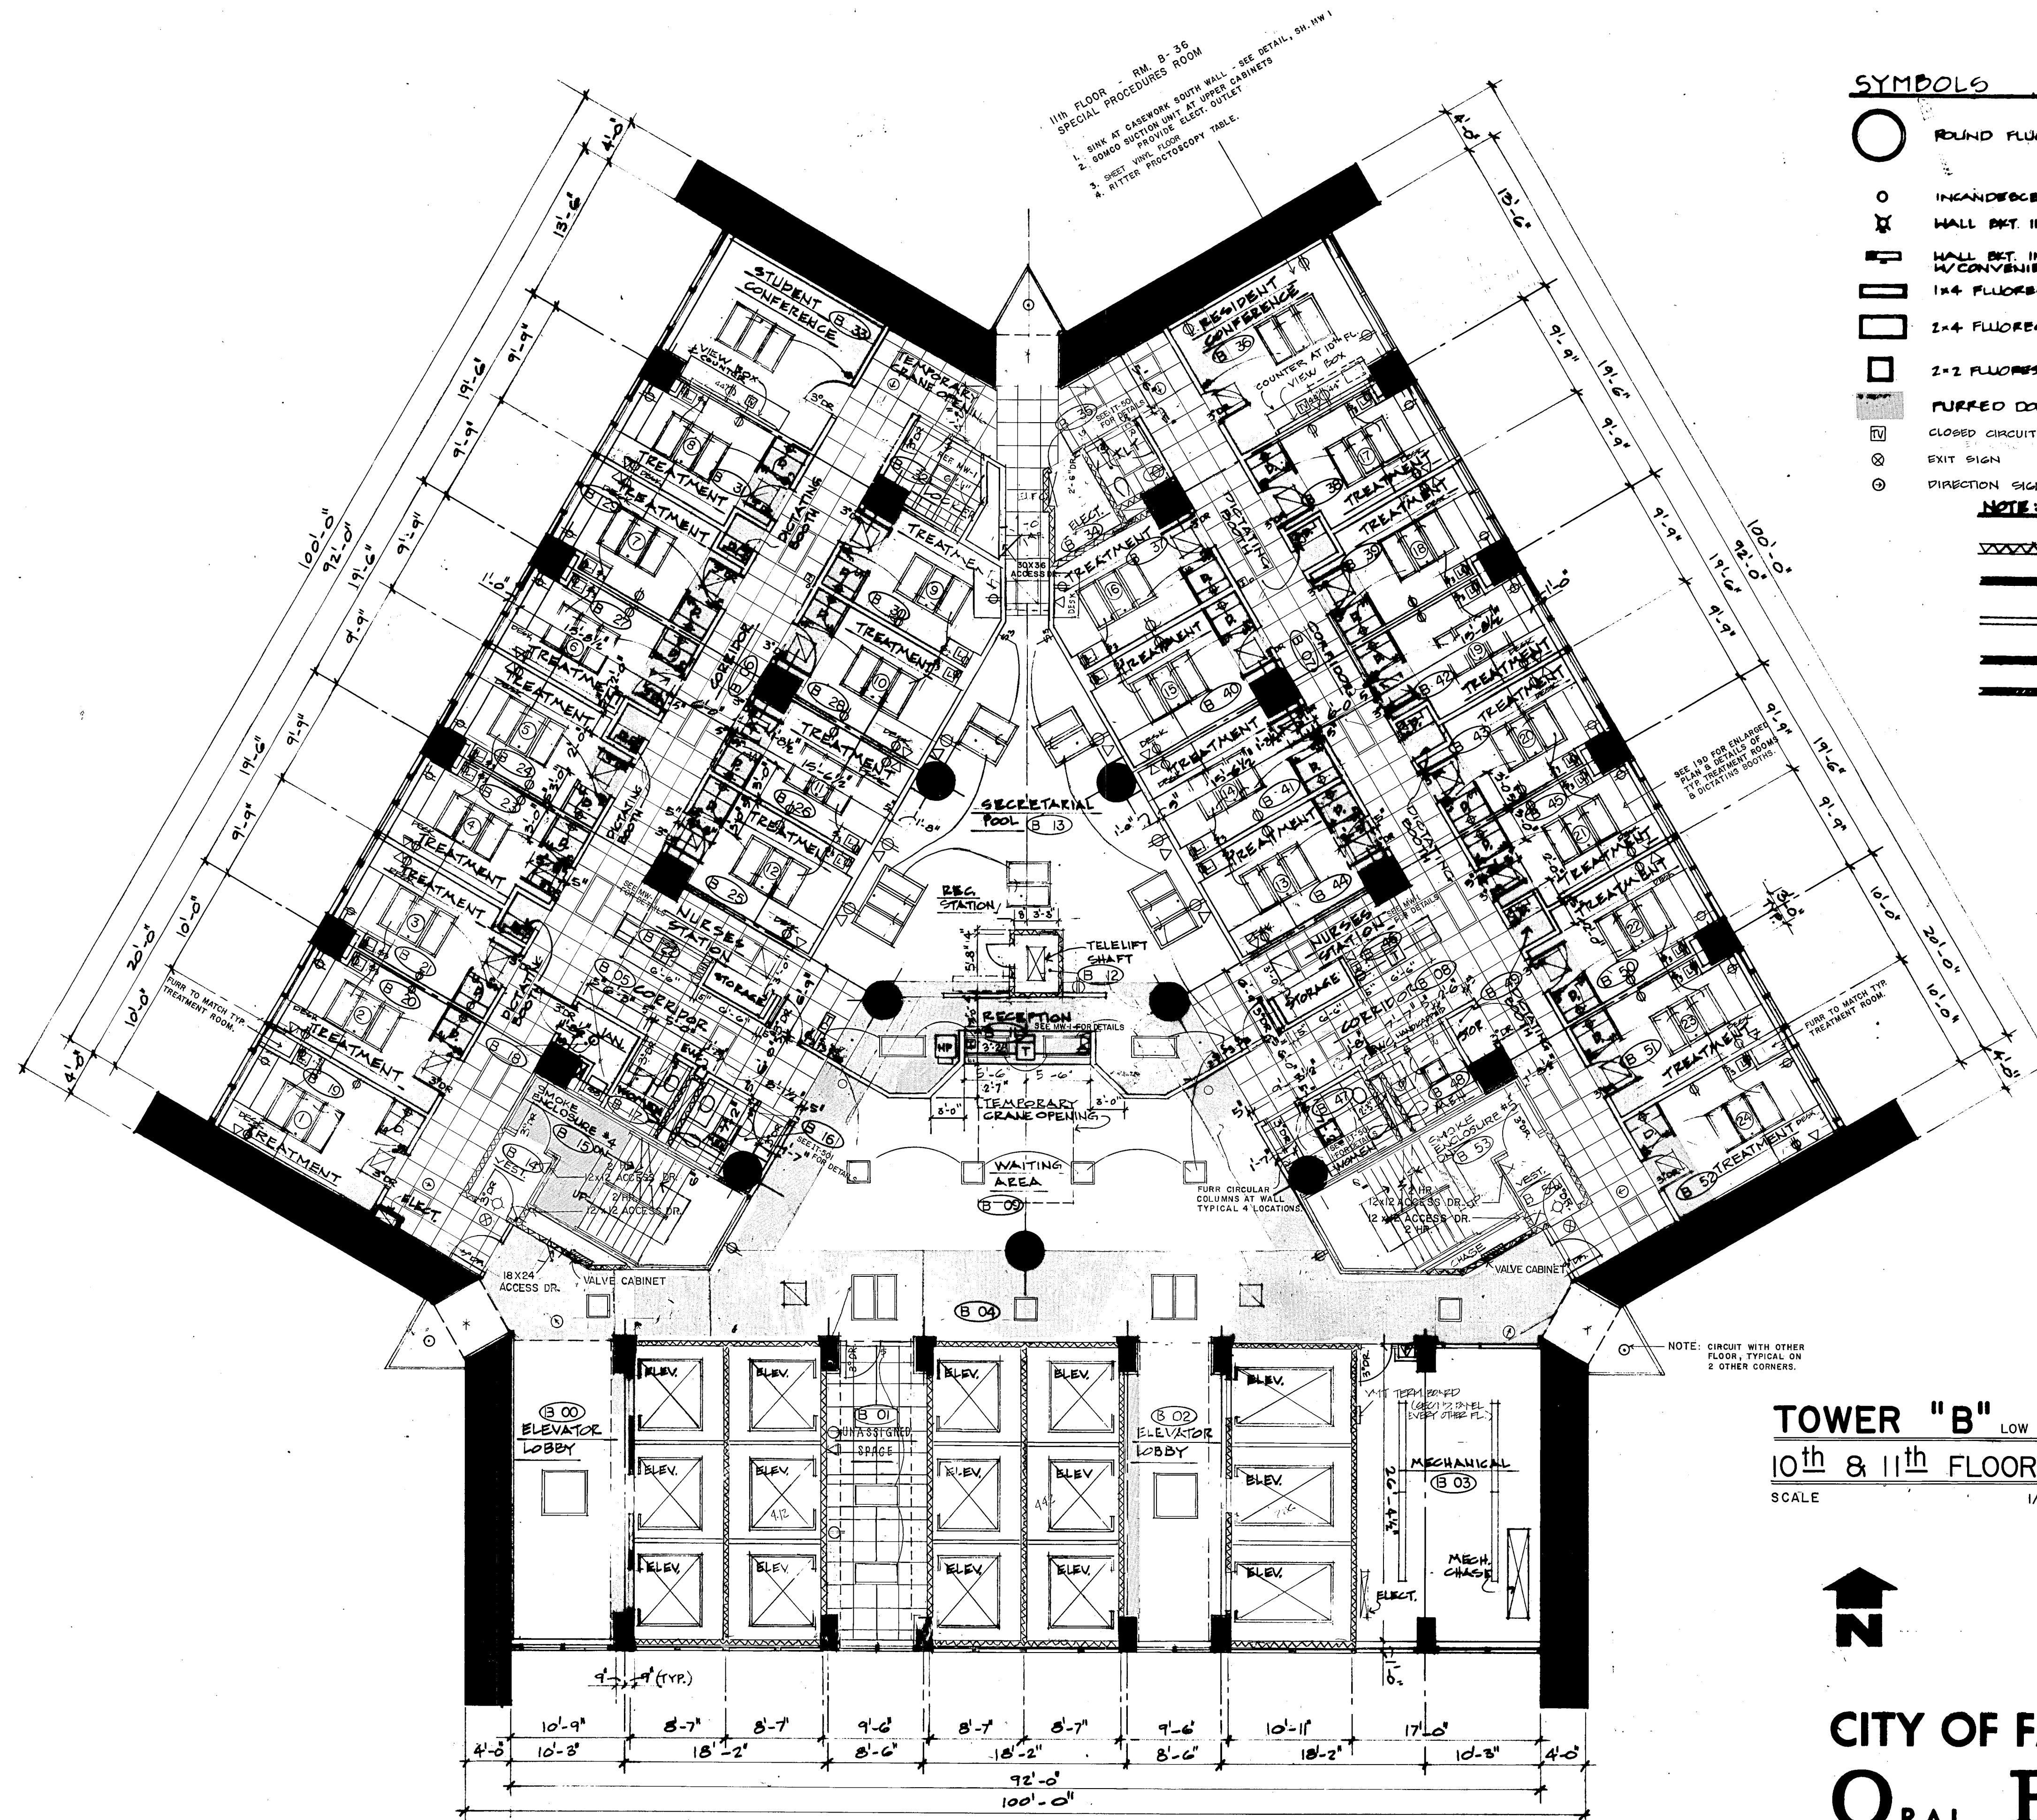

SYMBOLS LEGEND	
	ROUND FLUORESCENT LIGHT
	INCANDESCENT LIGHT
	WALL MNT. INCANDESCENT LT.
	WALL MNT. INCANDESCENT LT. W/ CONVENIENCE RECEPT.
	1x4 FLUORESCENT LT.
	2x4 FLUORESCENT LT.
	2x2 FLUORESCENT LT.
	FURRED DOWN CEILING
	CLOSED CIRCUIT TV
	EXIT SIGN
	DIRECTION SIGN
	PAY TELEPHONE
	TELEPHONE
	TELEPHONE W/ DICTATION
	SWITCH
	5 WAY SWITCH
	FLOOR OUTLET
	Pilot LT. SWITCH
	110V. ELECT. RECEPT. (87 A.R.F. UNLESS OTHERWISE NOTED)
	220V. ELECT. RECEPT.
	OXYGEN AIR VACUUM MEDICAL GAS OUTLETS
	6P. LOW SPEED PRINTER
	HP. HIGH SPEED PRINTER
	VIDEO MATRIX TERMINAL
	STAFF TIME CLOCK

NOTE: PARTITION KEY

XXXX ① 2 HR. RATED SMOKE PARTITION - 6"


XXXX ② 4 HR. RATED SMOKE PROOF ENCLOSURES - 6"

XXXX ③ METAL STUD WALLS 5/8" GYP. BD. EACH SIDE - 5"

XXXX ④ SHAFT WALL PARTITION - 2 HR. RATED - FIRE & SMOKE - 4"

XXXX ⑤ 1 HR. FIRE RATED PARTITION - 5"

TOWER "B" LOW RISE
10th & 11th FLOOR PLAN
SCALE 1/8" = 1' - 0"

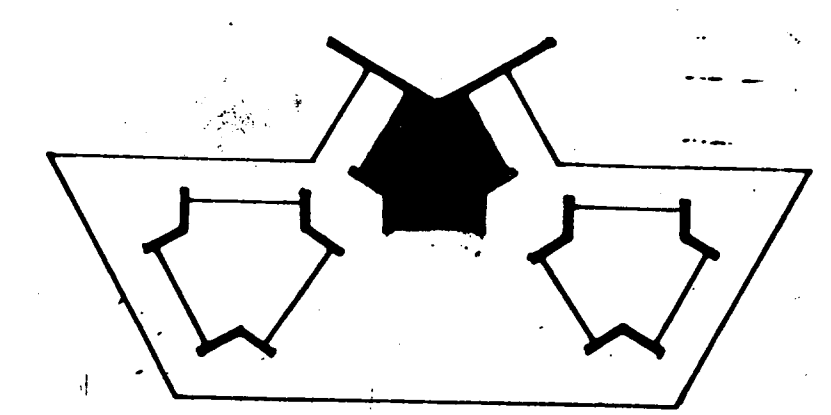

CITY OF FAITH
ORAL ROBERTS UNIVERSITY
7777 SOUTH LEWIS
TULSA, OKLAHOMA 74105

KEY PLAN

7-14-81
1-30-81
4-13-79
3-5-79
2-21-79
1-8-79
12-18-78
REVISIONS:
DATE ISSUED

HEALTH & INSTITUTIONAL CONSULTANTS
A SUBSIDIARY OF
KURT SALMON ASSOCIATES, INC.
ATLANTA, GEORGIA

FLYNT & KALLENBERGER, C.E.C.
CONSULTING MECHANICAL &
ELECTRICAL ENGINEERS
TULSA, OKLAHOMA

SNOWDEN ENGINEERING, INC.
CONSULTING
STRUCTURAL ENGINEER
TULSA, OKLAHOMA

FRANK W. WALLACE,
ARCHITECT
4564 SOUTH HARVARD
TULSA, OKLAHOMA 74135

SHEET
18/5
OF SHEETS